


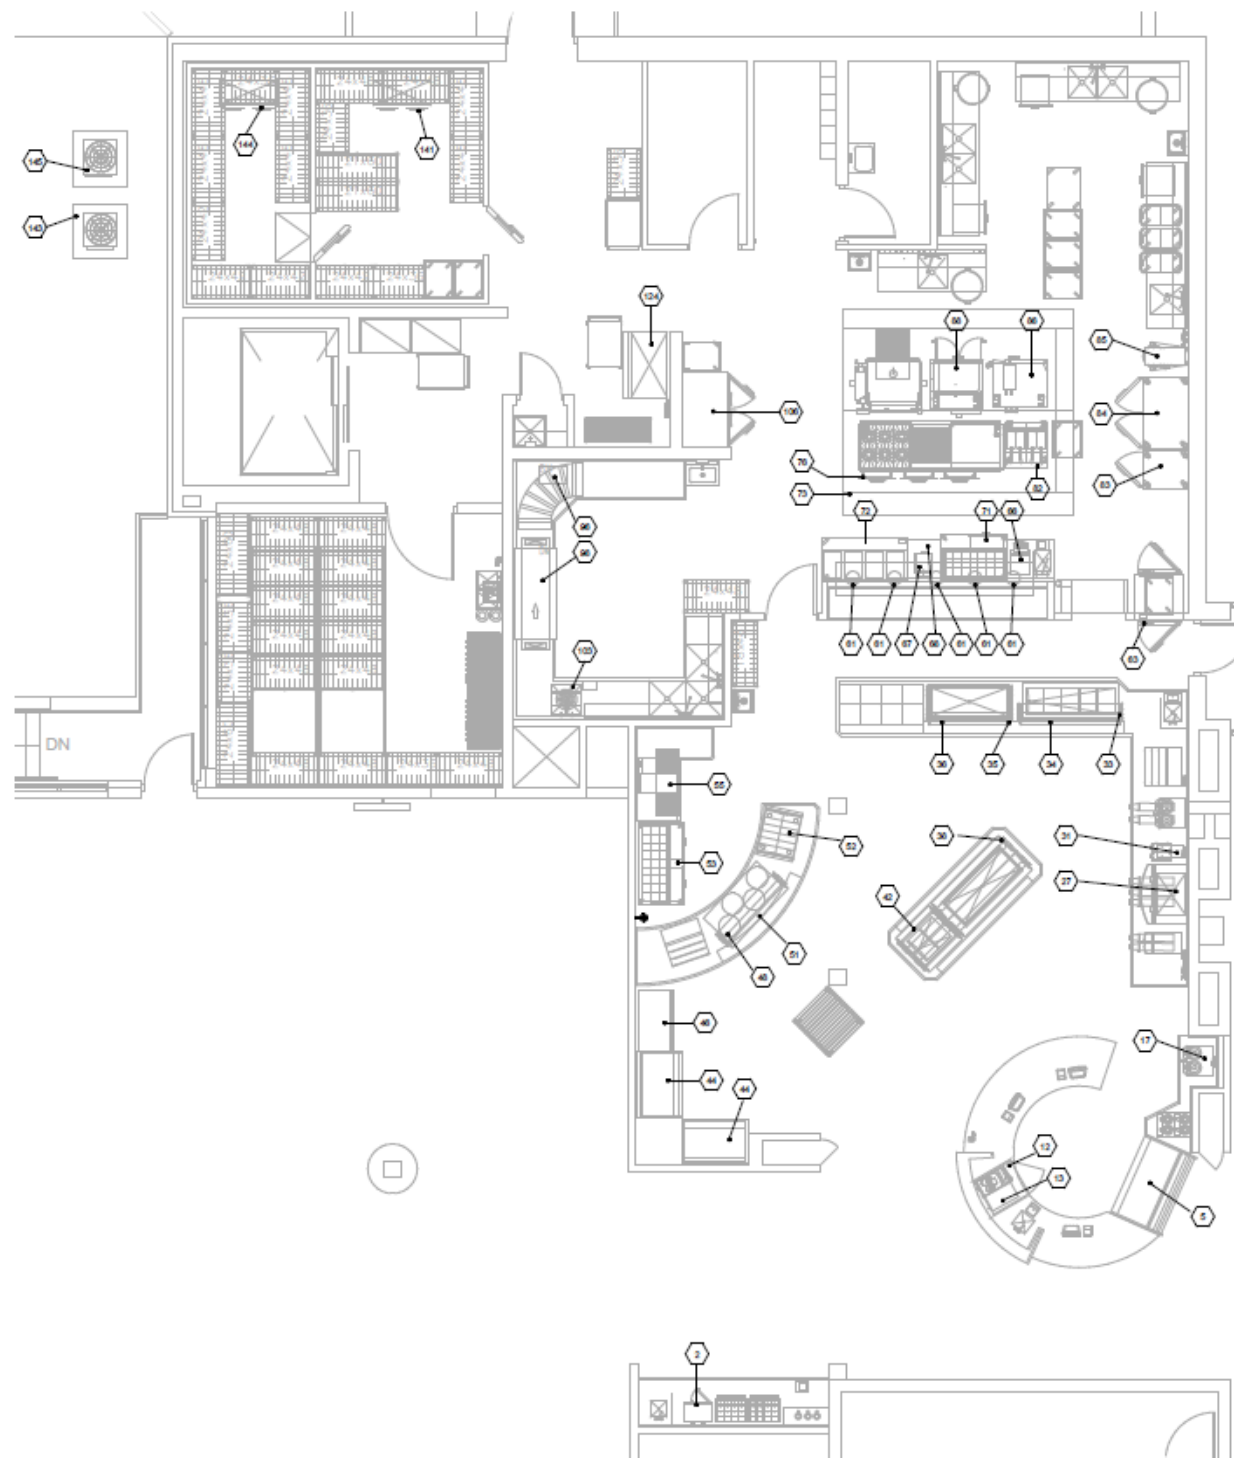

# GENERAL NOTES

1. REFER TO FOOD SERVICE DRAWINGS FOR ADDITIONAL INFORMATION.
2. COORDINATE ALL POWER CONNECTION REQUIREMENTS, DEVICE TYPES, RATINGS, AND MOUNTING LOCATIONS WITH ARCHITECTURAL AND FOOD SERVICE DRAWINGS.
3. COORDINATE WITH EQUIPMENT RATINGS FOR FINAL SIZING OF ALL CIRCUIT CONDUCTORS, OVERCURRENT PROTECTION, DEVICE TYPES, AND CONDUIT PER NEC REQUIREMENTS.

FOOD SERVICE EQUIPMENT SCHEDULE

| Tag | Description                                | Electrical Data  | Panel | Circuit Number | Comments |
|-----|--------------------------------------------|------------------|-------|----------------|----------|
| 2   | MICROWAVE                                  | 120 V/1-1600 VA  | BL-9  | 1              | 5-15P    |
| 5   | REFRIGERATED DISPLAY CASE                  | 208 V/2-2100 VA  | BL-9  | 2,4            | L14-20P  |
| 12  | UNDERCOUNTER REFRIGERATOR                  | 120 V/1-296 VA   | BL-9  | 6              | 5-15P    |
| 13  | ESPRESSO MACHINE                           | 208 V/2-500 VA   | BL-9  | 3,5            | L6-30R   |
| 17  | AIR POT COFFEE BREWER                      | 208 V/2-4500 VA  | BL-9  | 7,9            |          |
| 27  | CUBE ICE MAKER                             | 120 V/1-1440 VA  | BL-9  | 17             |          |
| 31  | NARROW ICE TEA BREWER                      | 120 V/1-500 VA   | BL-9  | 19             |          |
| 33  | 1-TIER FOOD SHIELD W/ LED LIGHTS/HEAT LAMP | 120 V/1-1603 VA  | BL-9  | 21             |          |
| 34  | 5 WELL HOT FOOD UNIT                       | 208 V/3-1240 VA  | BL-9  | 22,24,26       |          |
| 35  | FOOD SHIELD WITH LIGHTS                    | 120 V/1-1603 VA  | BL-9  | 23             |          |
| 36  | DROPHIN COLD PAN                           | 120 V/1-758 VA   | BL-9  | 25             |          |
| 38  | FOOD SHIELD WITH LED LIGHTS/HEAT LAMP      | 120 V/1-500 VA   | BL-9  | 20             |          |
| 42  | DROPHIN 2 WELL HOT FOOD UNIT               | 208 V/2-1348 VA  | BL-9  | 16,18          |          |
| 44  | REFRIGERATED DISPLAY CASE                  | 208 V/2-1750 VA  | BL-9  | 11,13          |          |
| 44  | REFRIGERATED DISPLAY CASE                  | 208 V/2-1750 VA  | BL-9  | 8,10           |          |
| 46  | REFRIGERATED GRAB AND GO                   | 120 V/1-500 VA   | BL-9  | 12             |          |
| 48  | 1-TIER FOOD SHIELD W/ LED LIGHTS/HEAT LAMP | 120 V/1-1603 VA  | BL-9  | 14             |          |
| 51  | DROPHIN HEATED SHELF                       | 120 V/1-1110 VA  | BL-9  | 15             |          |
| 52  | DISPLAY WARMER                             | 120 V/1-1020 VA  | BL-9  | 30             |          |
| 53  | REFRIGERATED PREP UNIT                     | 120 V/1-868 VA   | BL-9  | 28             |          |
| 55  | CONVEYOR PIZZA OVEN                        | 208 V/2-6000 VA  | BL-9  | 27,29          |          |
| 61  | DECORATIVE HEAT LAMP                       | 120 V/1-375 VA   | BL-3  | 2              |          |
| 61  | DECORATIVE HEAT LAMP                       | 120 V/1-375 VA   | BL-3  | 5              |          |
| 61  | DECORATIVE HEAT LAMP                       | 120 V/1-375 VA   | BL-3  | 2              |          |
| 61  | DECORATIVE HEAT LAMP                       | 120 V/1-375 VA   | BL-3  | 5              |          |
| 61  | DECORATIVE HEAT LAMP                       | 120 V/1-375 VA   | BL-3  | 2              |          |
| 63  | ROLL TRU WARMER                            | 208 V/2-1500 VA  | BL-3  | 15,17          |          |
| 66  | CONVEYOR TOASTER                           | 120 V/1-1800 VA  | BL-3  | 6              |          |
| 67  | PANINI PRESS                               | 120 V/1-1675 VA  | BL-3  | 4              |          |
| 68  | DIPPER WELL                                | 120 V/1-100 VA   | BL-3  | 1              |          |
| 71  | REFRIGERATED PREP UNIT                     | 120 V/1-500 VA   | BL-3  | 8              |          |
| 72  | MOBILE 5-WELL HOT FOOD UNIT                | 120 V/1-3000 VA  | BL-3  | 7              |          |
| 73  | ISLAND HOOD                                | 120 V/1-500 VA   | BL-3  | 30             |          |
| 76  | REFRIGERATED EQUIPMENT STAND               | 120 V/1-540 VA   | BL-3  | 35             |          |
| 82  | FRYER                                      | 120 V/1-500 VA   | BL-3  | 27             |          |
| 83  | FREEZER                                    | 120 V/1-500 VA   | BL-3  | 25             |          |
| 84  | REFRIGERATOR                               | 120 V/1-500 VA   | BL-3  | 9              |          |
| 85  | 40 QT MIXER                                | 120 V/1-500 VA   | BL-3  | 3              |          |
| 86  | COMBI DOUBLE OVEN                          | 208 V/2-1000 VA  | BL-3  | 10,12          |          |
| 88  | CONVECTION OVEN                            | 120 V/1-500 VA   | BL-3  | 26             |          |
| 95  | BOOSTER HEATER                             | 208 V/3-11773 VA | BL-3  | 38,40,42       |          |
| 98  | DISH MACHINE                               | 120 V/1-500 VA   | BL-3  | 28             |          |
| 103 | DISPOSAL                                   | 208 V/2-2516 VA  | BL-3  | 22,24          |          |
| 106 | REFRIGERATOR                               | 120 V/1-500 VA   | BL-3  | 23             |          |
| 134 | ICE MAKER                                  | 120 V/1-500 VA   | BL-3  | 29             |          |
| 141 | BLOWER COIL - COOLER                       | 208 V/2-2080 VA  | BL-3  | 19,21          |          |
| 143 | REMOTE CONDENSING UNIT - COOLER            | 208 V/2-728 VA   | BL-3  | 11,13          |          |
| 144 | BLOWER COIL - FREEZER                      | 208 V/2-2080 VA  | BL-3  | 18,20          |          |
| 145 | REMOTE CONDENSING UNIT - FREEZER           | 208 V/2-1560 VA  | BL-3  | 14,16          |          |

ENLARGED PLAN - FOOD SERVICE EQUIPMENT  
1/4" = 1'-0"

Project Name and Address

Wood Dining  
Operational  
Enhancements  
Volunteer State  
Community College

1480 Nashville Pike  
Gallatin, Sumner County, TN



SBC NO. 166/025-03-2021

Project Name and Address

PROJX LLC  
507A Heather Place  
Nashville, Tennessee 37204  
Phone: 615.277.1178  
Website: www.projx.com



RUBICON Engineering Services LLC  
11225 Lebanon Rd #40  
Mount Juliet, TN 37122  
(615) 879-0610  
www.rubiconengineering.com

PROJX NO: 210903

Seal of the State of Tennessee



General Notes  
THIS DOCUMENT CONTAINS INFORMATION THAT IS PROPRIETARY TO PROJX, LLC, AND IS FURNISHED FOR THE LIMITED PURPOSES OF EVALUATION, BIDDING, OR REVIEW. THIS DOCUMENT AND / OR ITS CONTENTS MAY NOT BE USED FOR ANY OTHER PURPOSE AND MAY NOT BE REPRODUCED OR DISCLOSED IN WHOLE OR PART TO OTHERS WITHOUT THE PRIOR WRITTEN CONSENT OF PROJX, LLC. COPYRIGHT 2020, ALL RIGHTS RESERVED.

ELECTRICAL  
POWER PLAN -  
FOOD SERVICE  
EQUIPMENT

| No. | Revisions/Notes | Date |
|-----|-----------------|------|
|     |                 |      |
|     |                 |      |
|     |                 |      |

Date: 05/31/2022  
Drawn By: DLG  
Checked By: DLG

E5.1